


**PLAN LAYOUT (WEST)**

SCALE @ A1: 1:250  
SCALE @ A3: 1:500

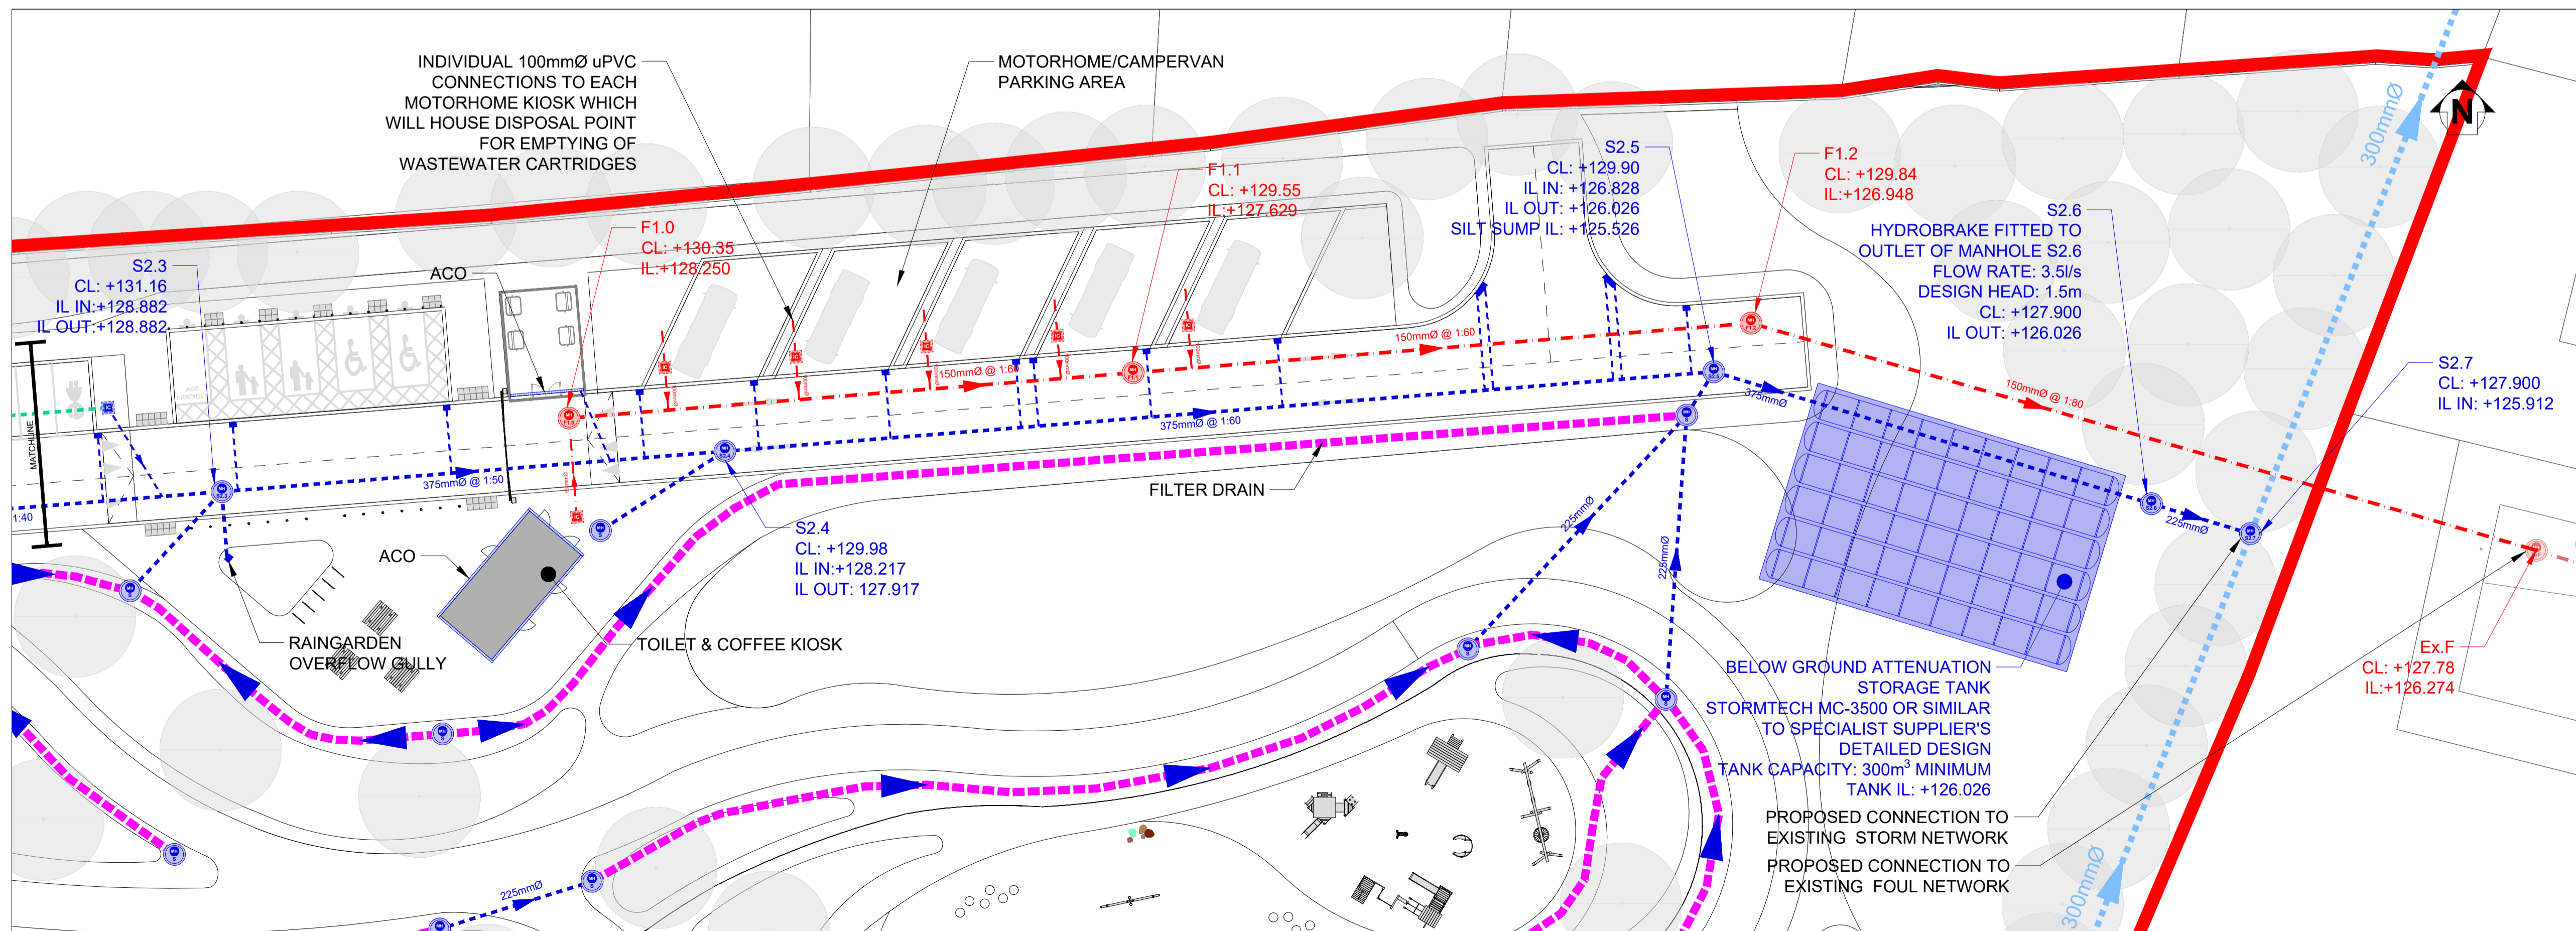



**PLAN LAYOUT (EAST)**

SCALE @ A1: 1:250  
SCALE @ A3: 1:500

**NOTES**

- THIS DRAWING IS TO BE READ IN CONJUNCTION WITH ALL ENGINEERS & ARCHITECTS' DRAWINGS FIGURED DIMENSIONS ONLY (NOT SCALING) TO BE USED. WHERE A CONFLICT OF INFORMATION EXISTS OR IF IN ANY DOUBT - 'ASK'.
- CONSULTANTS TO BE INFORMED IMMEDIATELY OF ANY DISCREPANCIES BEFORE WORK PROCEEDS.

**DRAINAGE LEGEND**

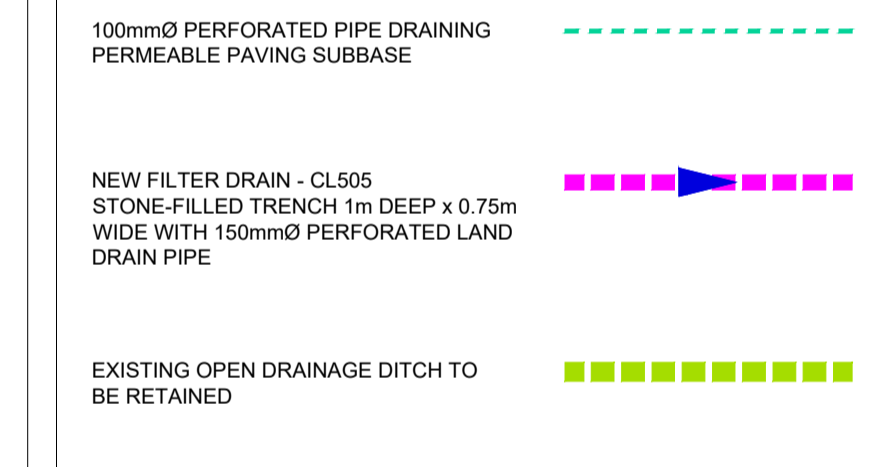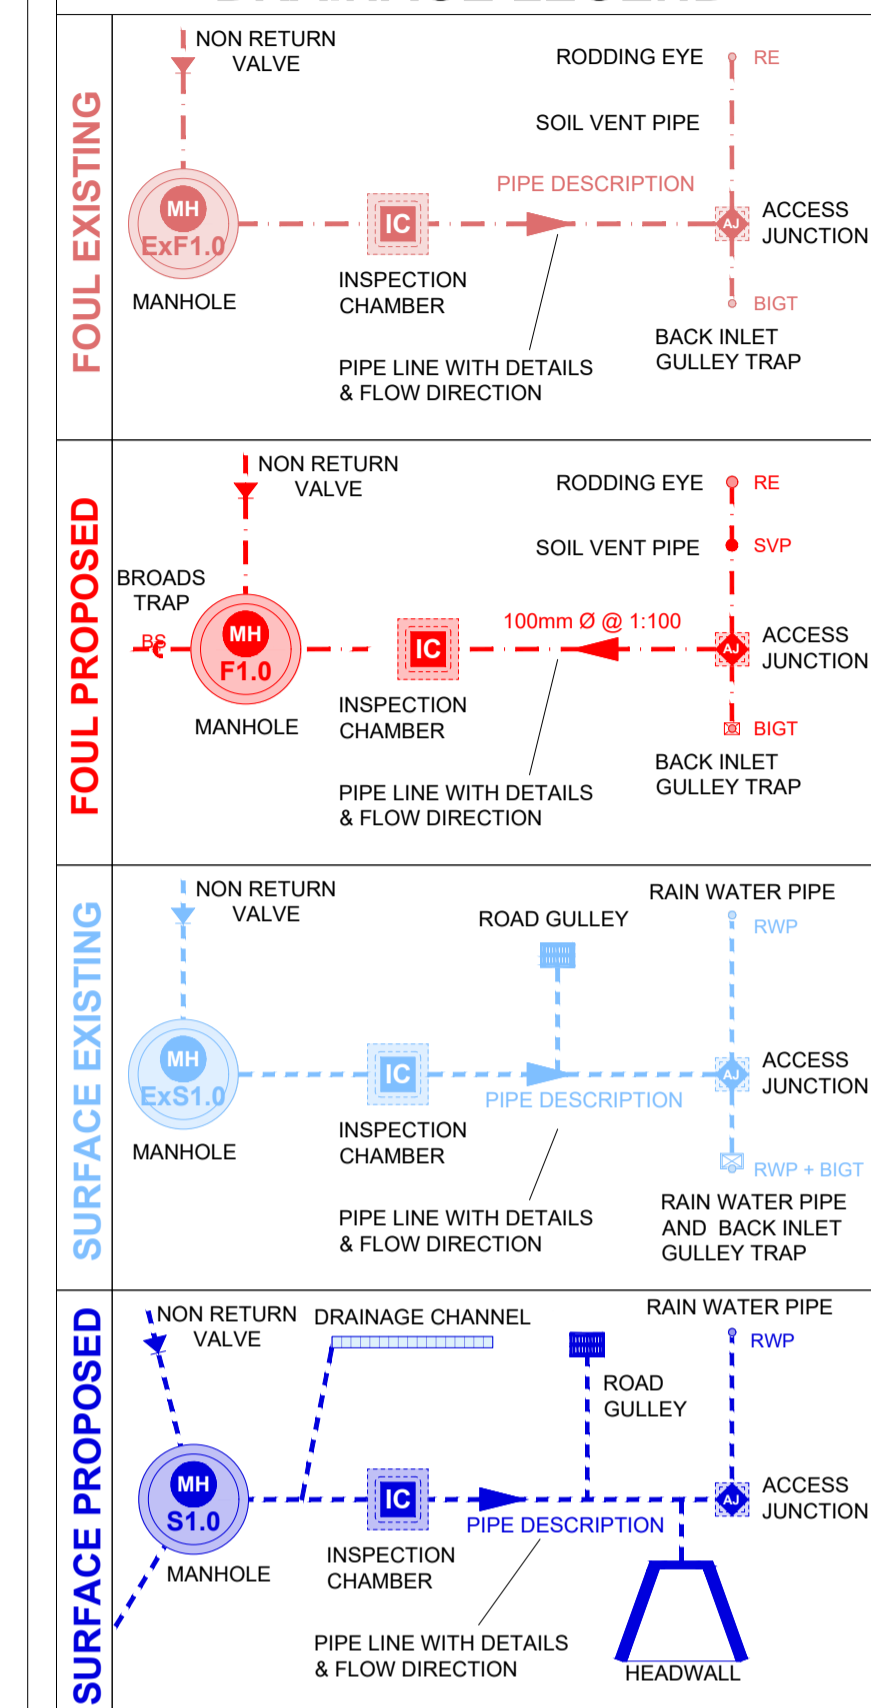

**NOTE:** ALL WASTEWATER DRAINAGE WORKS TO BE CARRIED OUT STRICTLY IN ACCORDANCE WITH UIJSC EIREANN'S LATEST STANDARD DETAILS AND CODES OF PRACTICE.

| PL1   | 21.05.26 | ISSUED FOR PLANNING | PS  | POD  |
|-------|----------|---------------------|-----|------|
| ISSUE | DATE     | DESCRIPTION         | DRN | P.D. |
|       |          |                     | DRN | P.D. |

DRAWING STAGE **PLANNING**

**BM**  
BARRITT MAHONY  
Consulting Engineers, Civil, Structural, Project Management. E-mail: bmcs@bmce.ie Web: www.bmce.ie

Dublin Office: Sandwith House, 53-54 Lower Sandwith Street, Dublin 2, Ireland. Tel: (01) 677 3200 Fax: (01) 677 3184  
London Office: 5th Floor, Mill House, 8 Mill Street, London SE1 2BA, United Kingdom Tel: (0044) 20 3750 3530

**Cavan** logo and other logos: Ar d'Tochtaí Tuaithe, Rialtas na hÉireann, Tionscadal Éireann 2040

CLIENT **CAVAN COUNTY COUNCIL**

PROJECT TITLE **CORNAHILT, BALLYJAMESDUFF, CO. CAVAN** BM PROJECT No. **25.263**

MODEL REFERENCE MODEL REV. SUITABILITY

DRAWING TITLE **DRAINAGE PLAN LAYOUT NORTHERN AREA**

DRAWING No. **25263-BMD-ZZ-XX-DR-C-1021** ISSUE **PL1**